



CONCEPT FLOOR PLAN

SCALE: 1"=20'

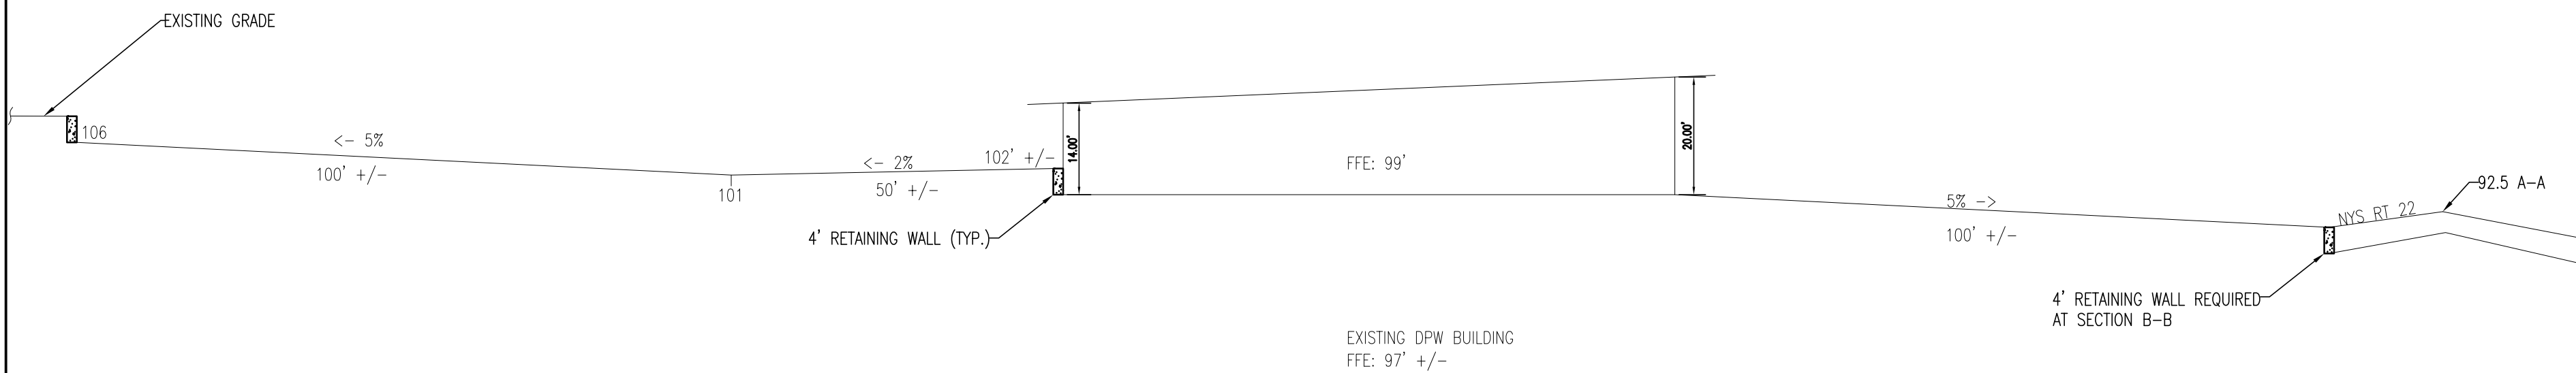

CONCEPT SECTION A-A/B-B

SCALE: 1"=20'

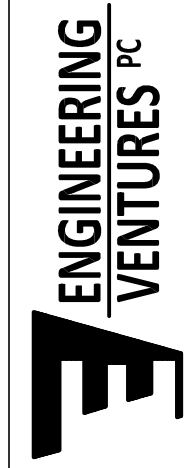

**ENGINEERING
VENTURES PC**
208 Flynn Avenue, Suite 2A Burlington, VT 05401
tel. 802.863.6225 • fax 802.863.6306
85 Mechanic Street, Suite B2-2, Lebanon, NH 03766
tel. 603.442.9333 • fax 603.442.9331
www.engineeringventures.com

Client:
TOWN OF
WESTPORT NY

22 Champlain Ave / P.O. Box 46
Westport, NY 12993
(518)962-4419

Sheet Title:
**CONCEPT FLOOR PLAN &
SECTION A-A/B-B**

Project Title:
**WESTPORT HIGHWAY - FIRE RESCUE
GARAGES**
WESTPORT, NY

Designed By:	PG
Checked By:	PG
Drawn By:	DZ
Scale:	AS NOTED
Date:	11/9/2012

C1.0

EV#11712